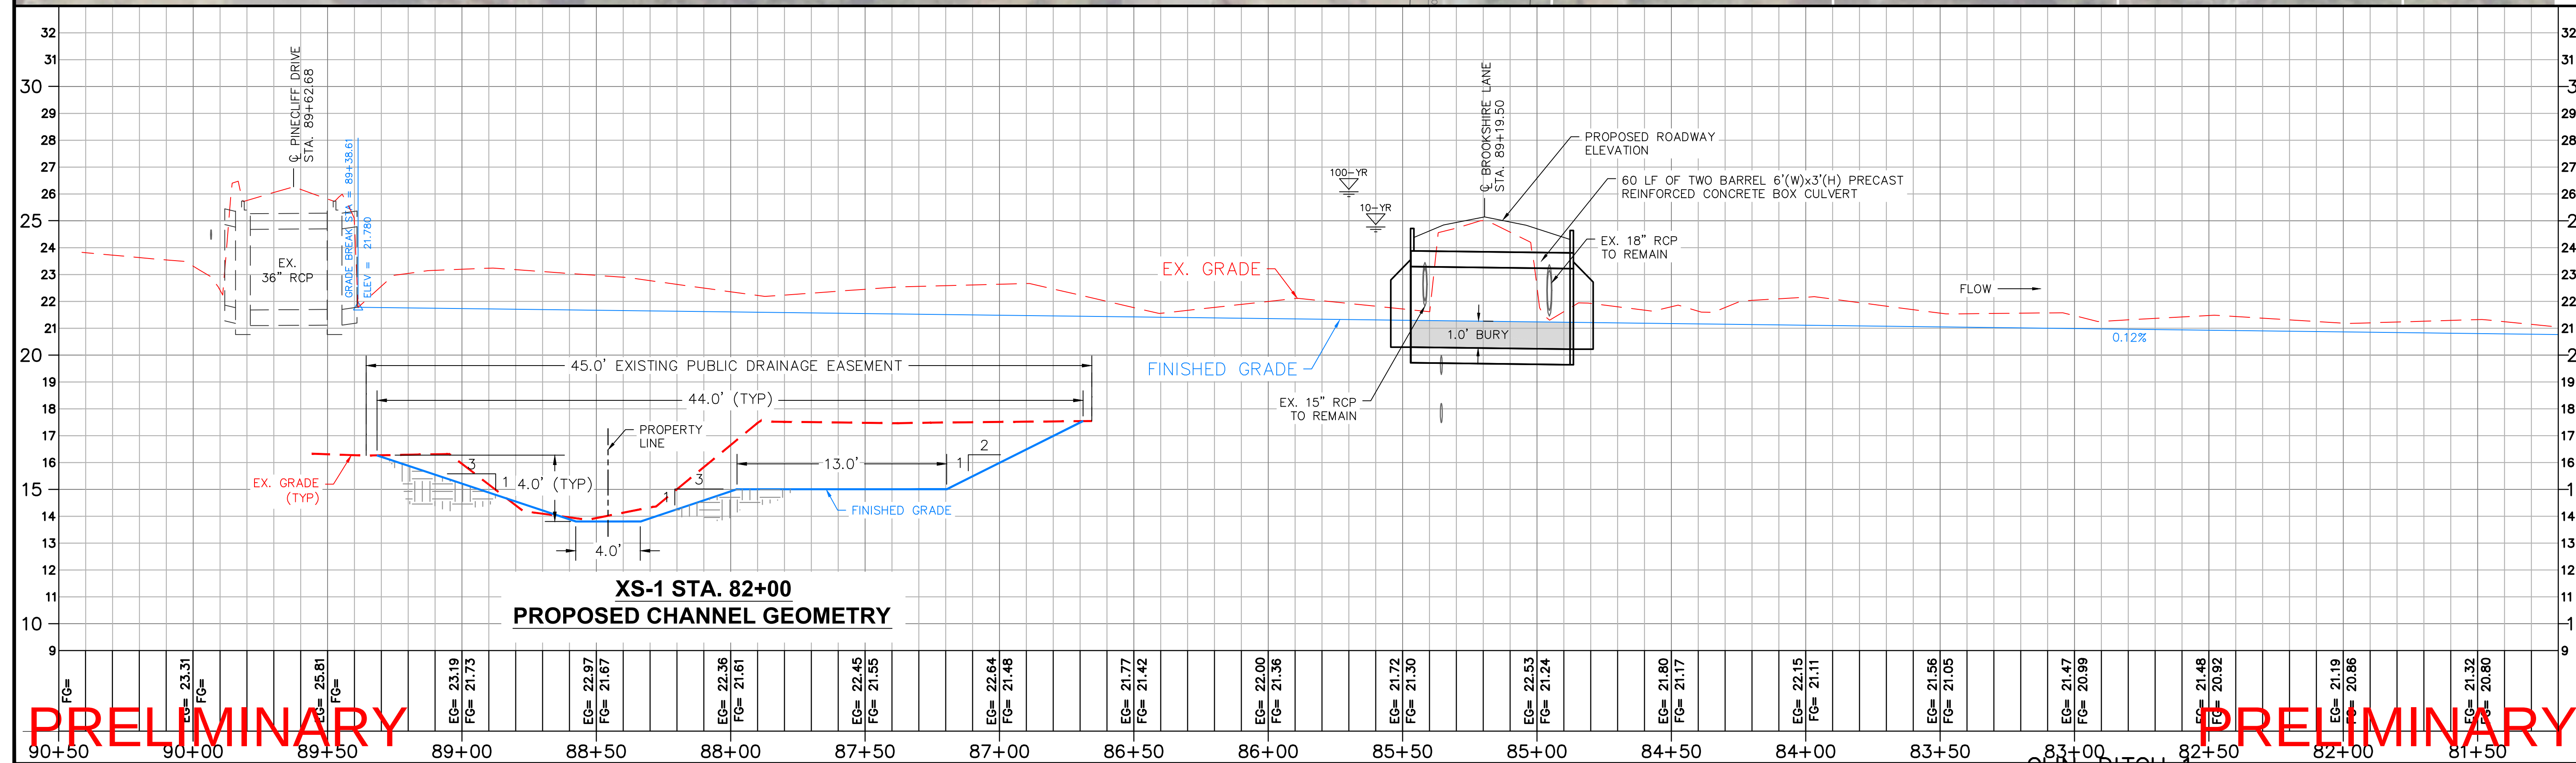
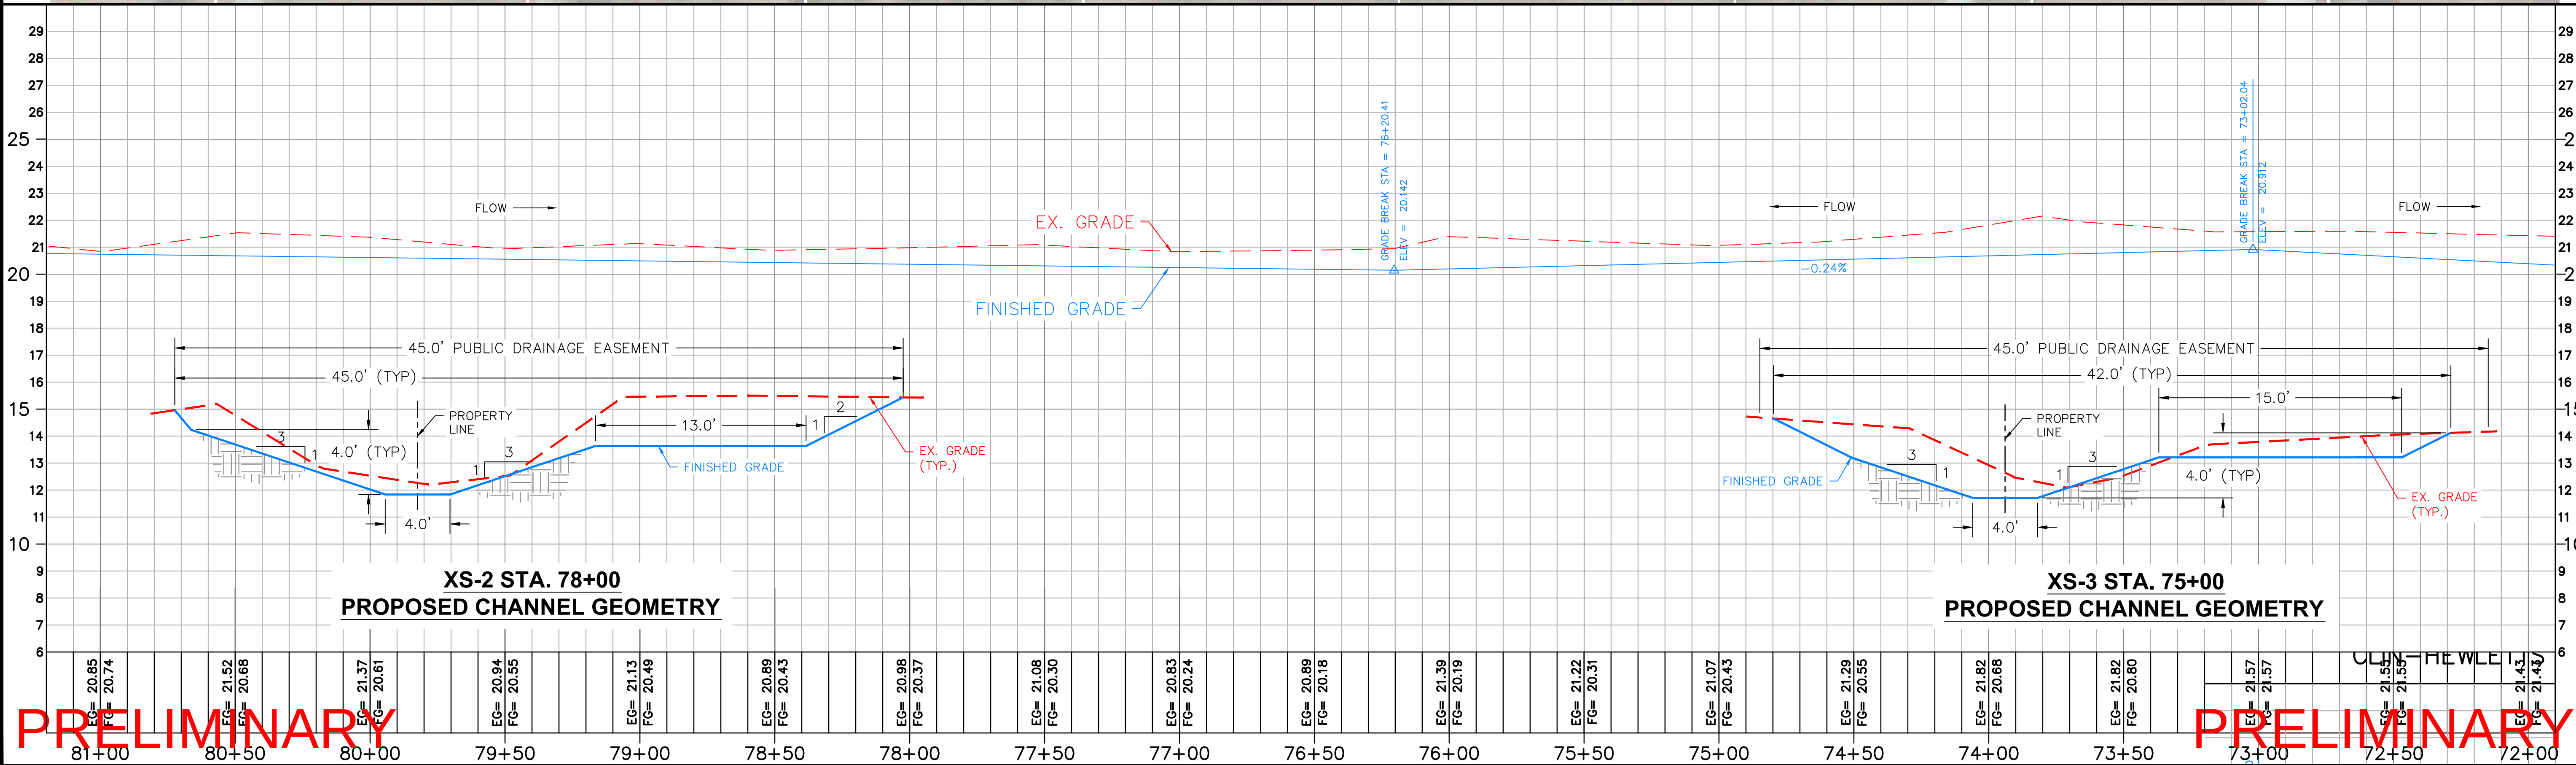


PRELIMINARY


PRELIMINARY

[illegible]


PRELIMINARY

[illegible]

PRELIMINARY

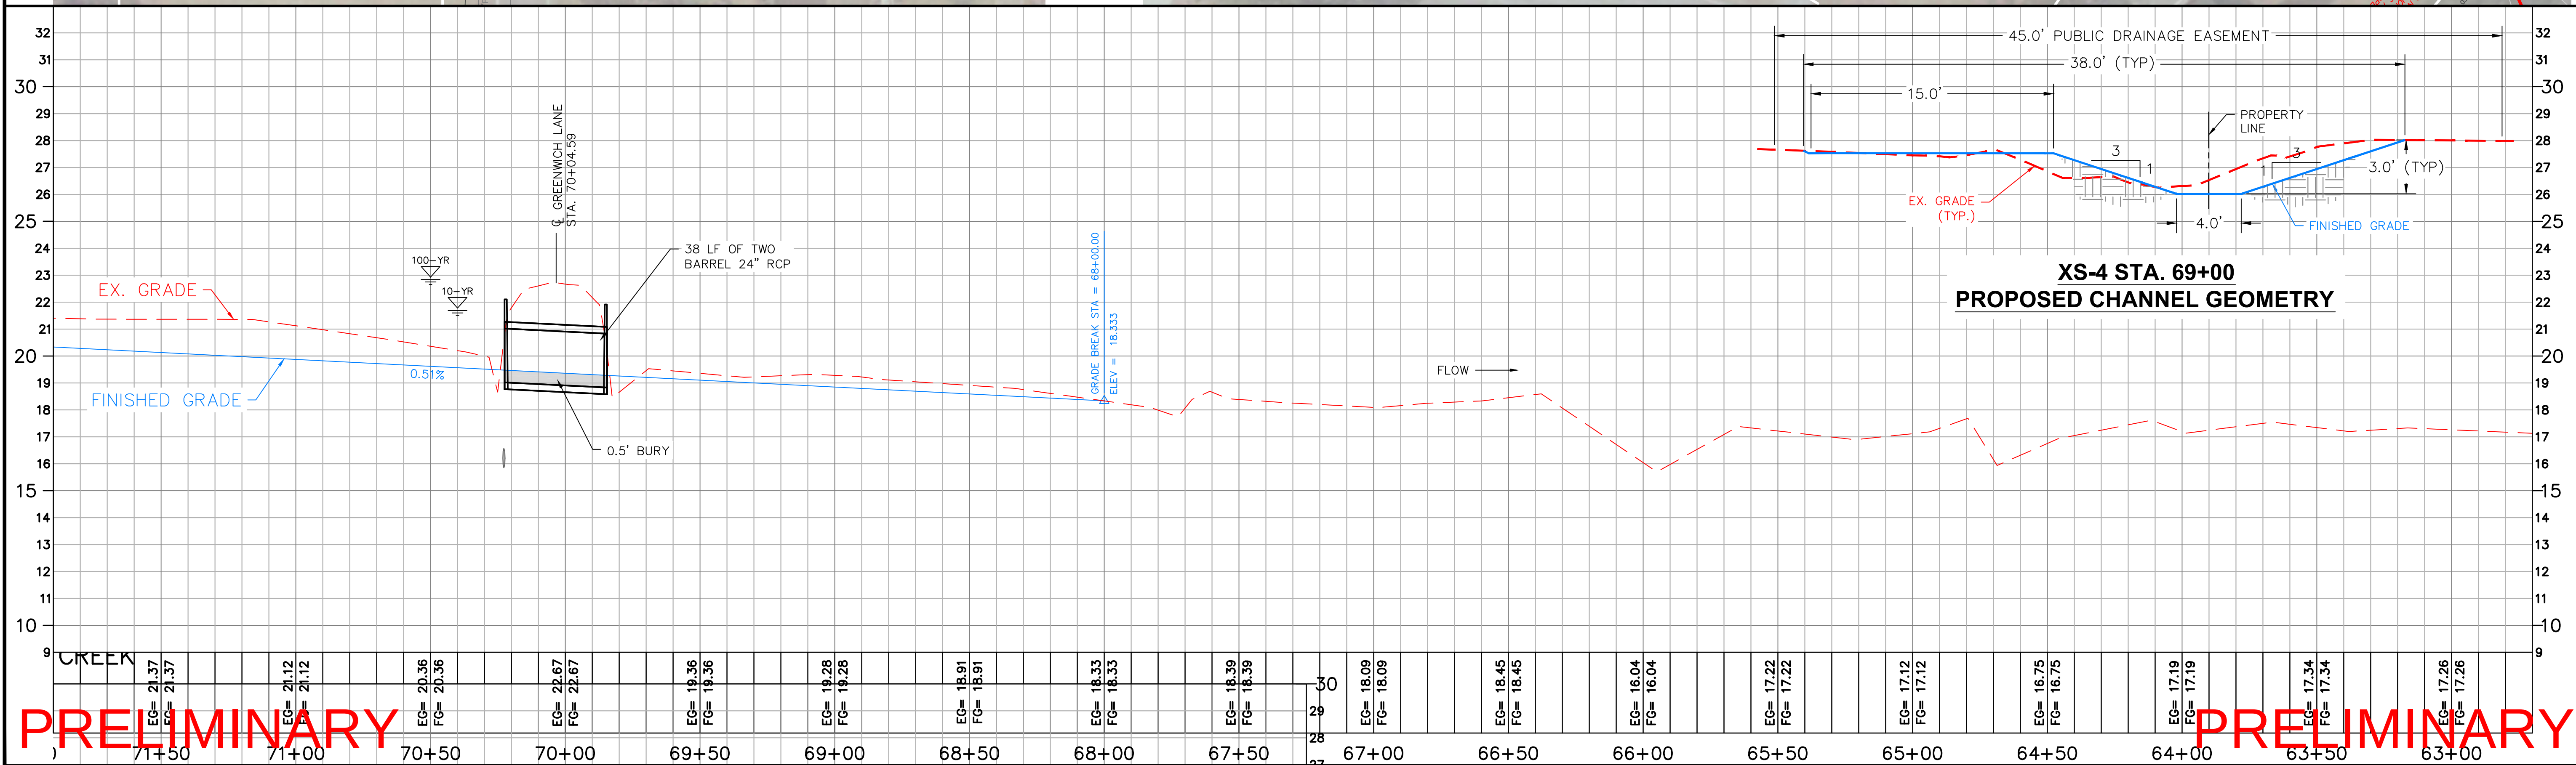


PRELIMINARY

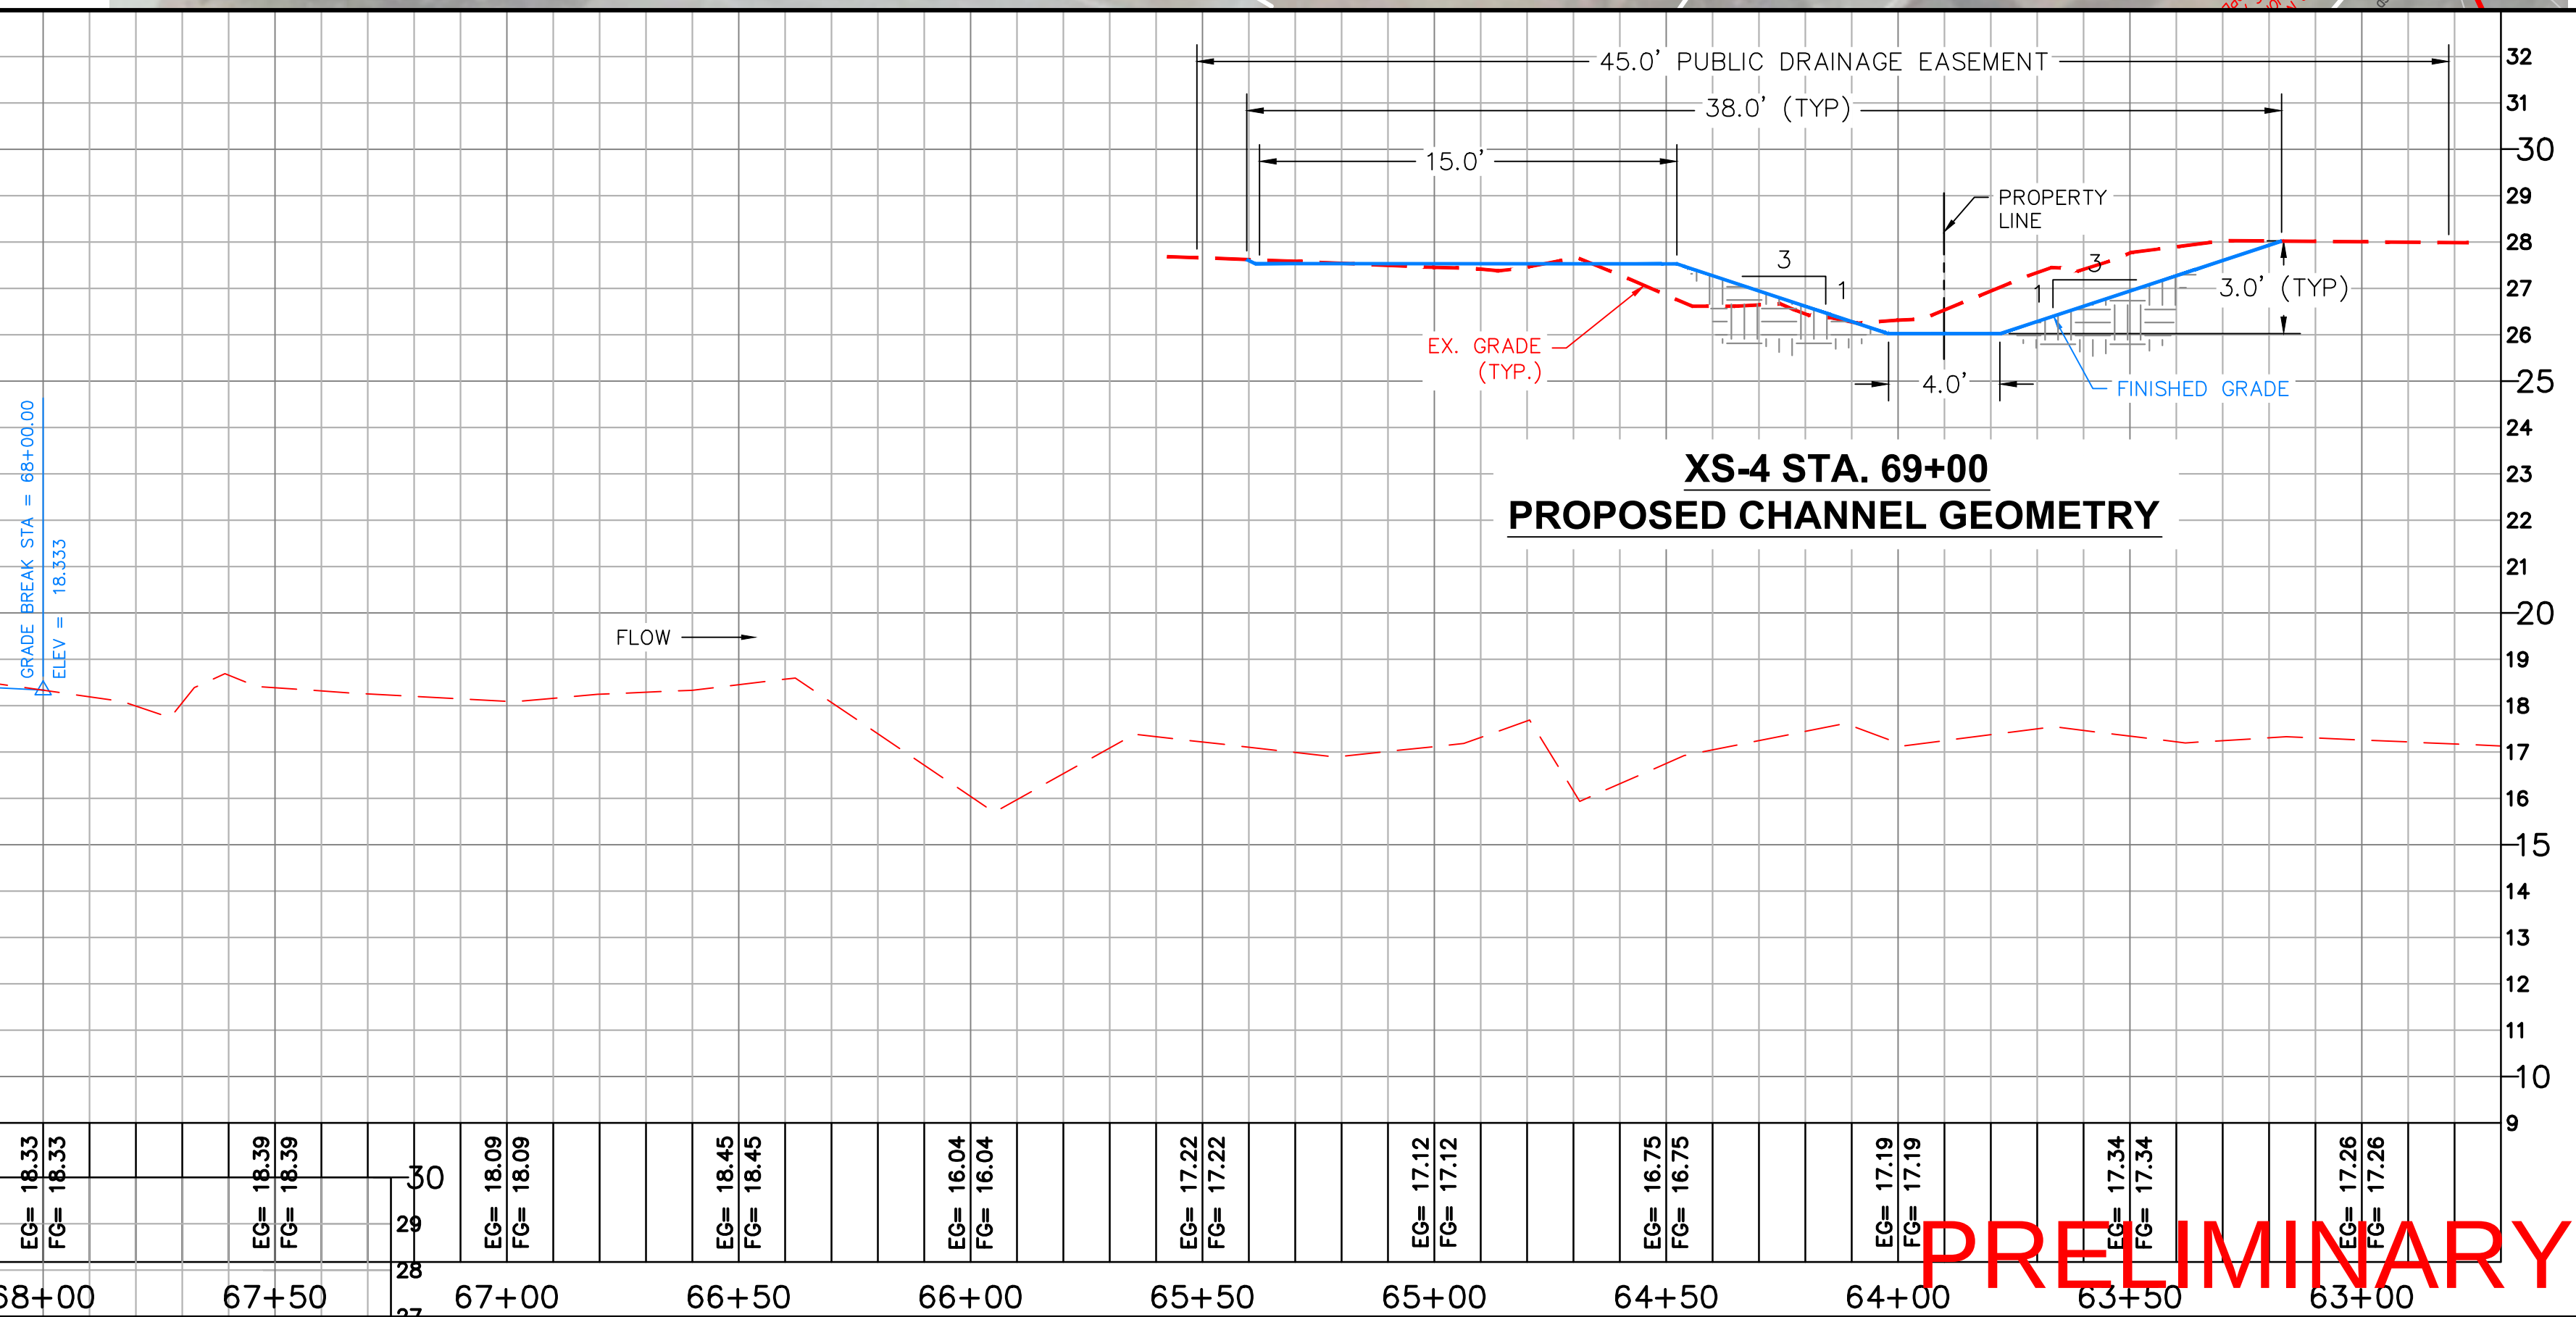

CITY OF WILMINGTON - STORMWATER SERVICES BROOKSHIRE LANE/BEASLEY ROAD STORMWATER IMPROVEMENTS CITY OF WILMINGTON CONTRACT NO. S6-0511.2 DAVID B. MAYES, PE, STORMWATER SERVICE MANAGER		DITCH #JUHREWETTS CREEK - PLAN AND PROFILE	
SHEET <u>3</u> OF 12 SHEETS SCALE: 1"=30'		URS PROJECT # 31828773 DATE: 03/11/14	
C-103			


PRELIMINARY

PRELIMINARY

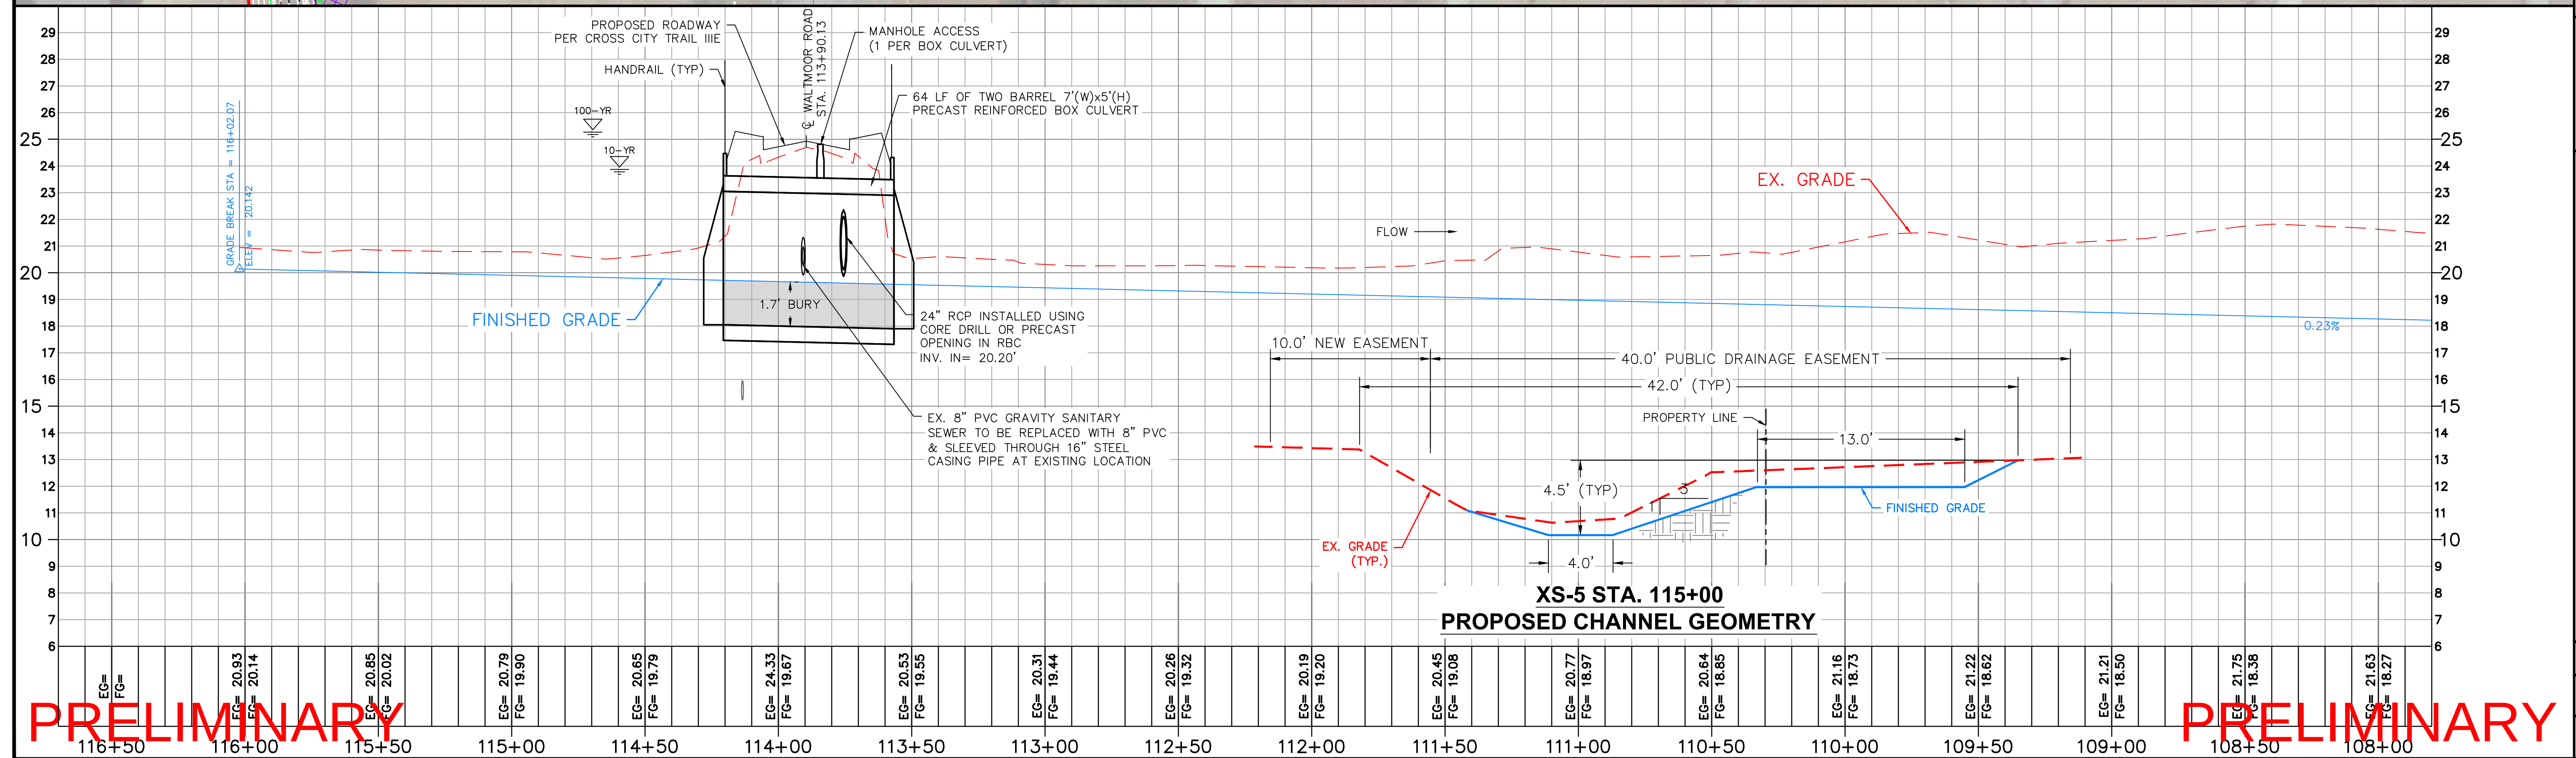[illegible]

PRELIMINARY

PRELIMINARY

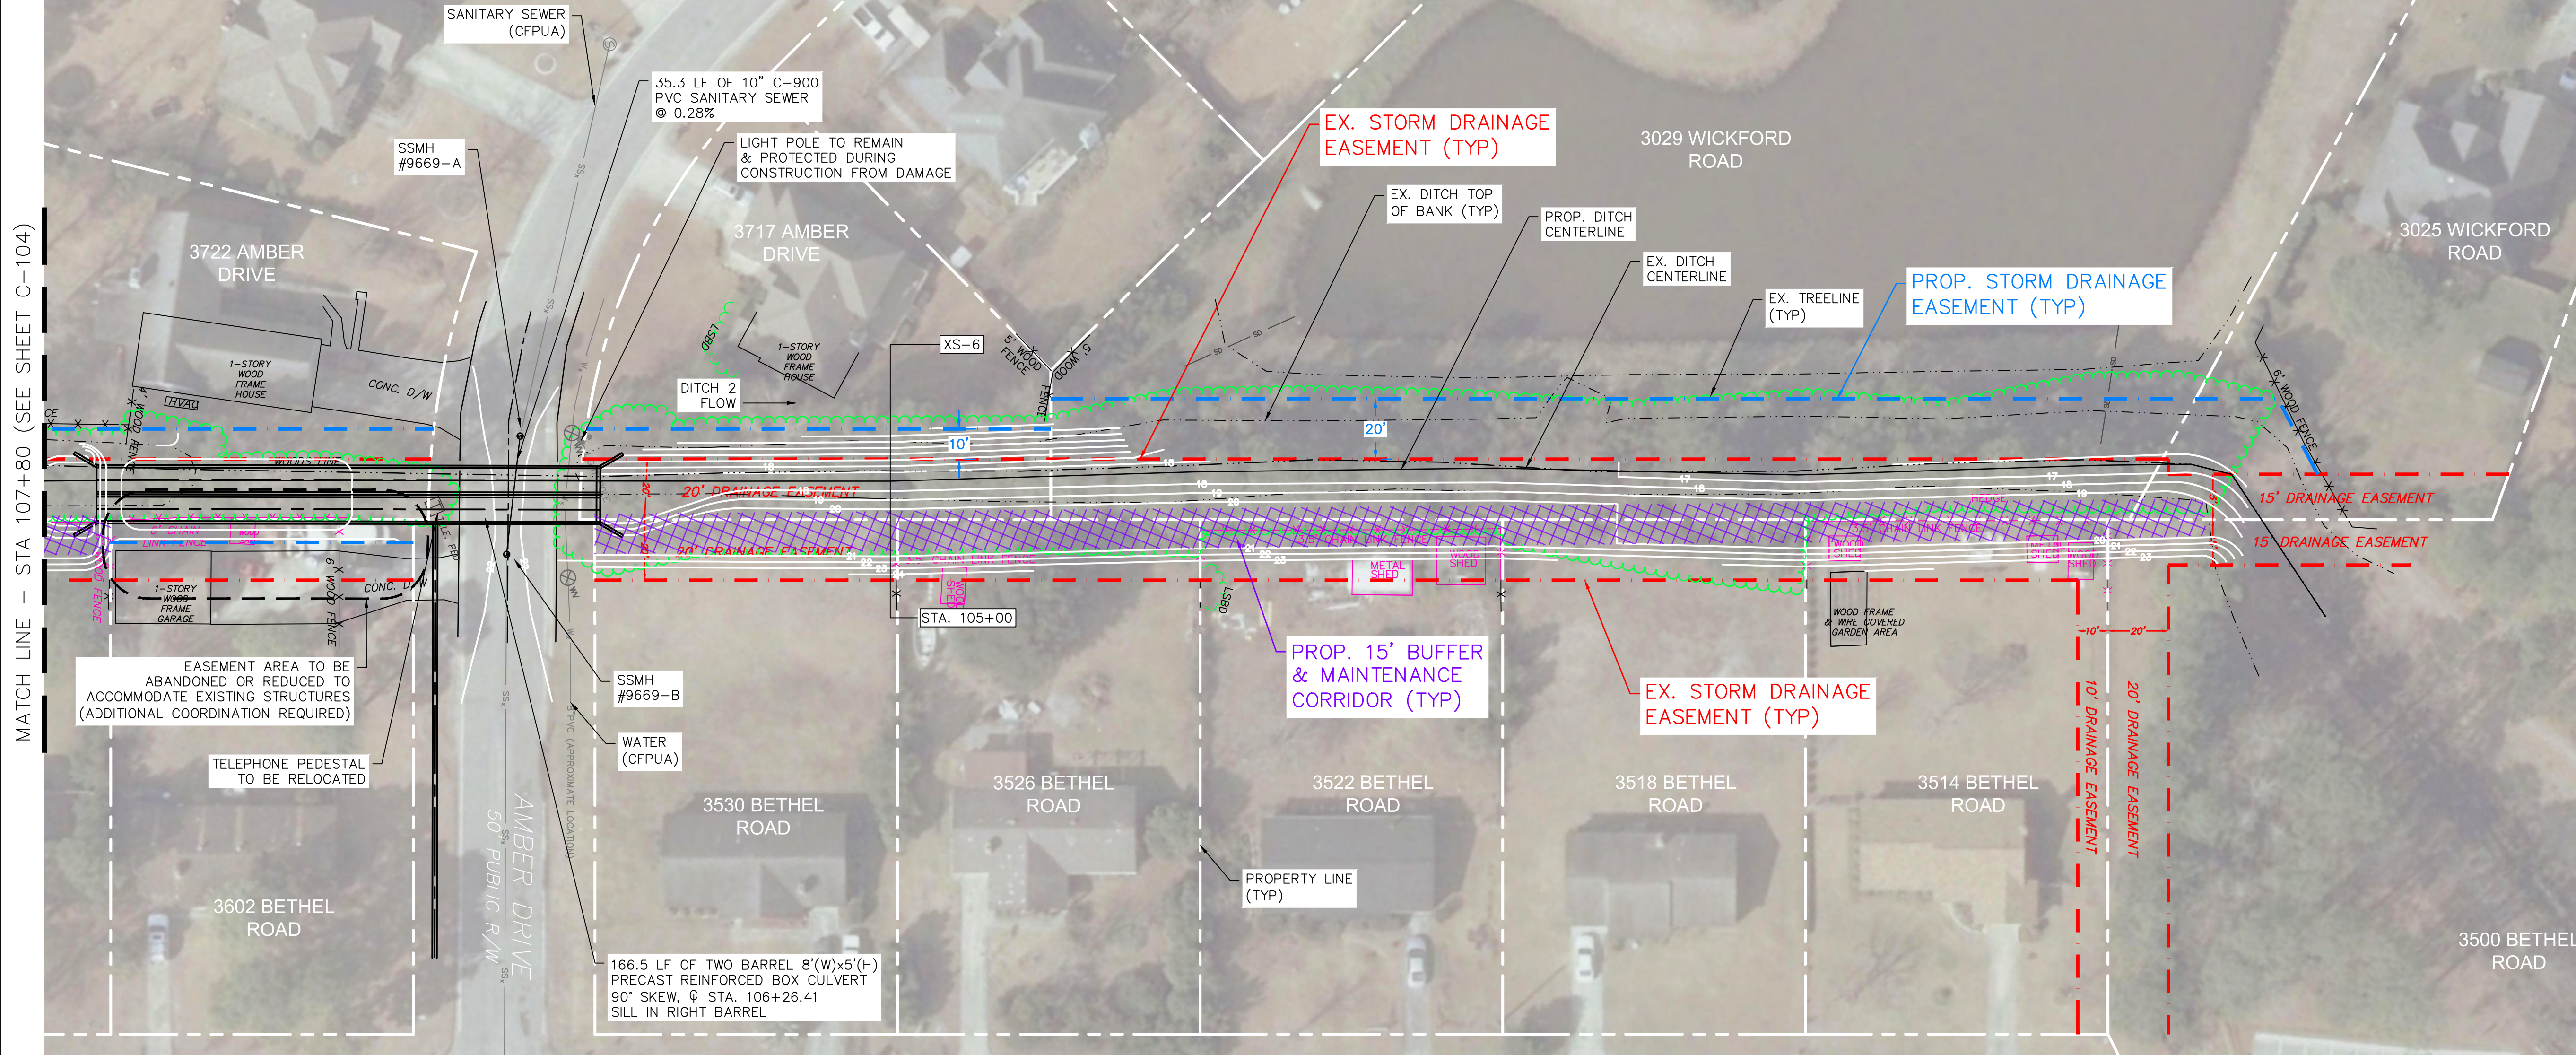

EXISTING SANITARY SEWER NETWORK
(AMBER DRIVE)

SSMH #9670
TOP = 23.64
INV OUT = 17.98 (TO SSMH #9669)


SSMH #9669 (TO BE REMOVED)
TOP = 21.66 (BENCH MARK)
INV IN = 17.47 (FROM SSMH #9670)
INV OUT = 17.37 (TO SSMH #9762)

SSMH #9762
TOP = 23.17
INV IN = 16.68 (FROM SSMH #9669)



PROPOSED SANITARY SEWER NETWORK
(AMBER DRIVE)

SSMH #9669-A
TOP = 22.16
INV IN = 17.54
INV OUT = 17.41

SSMH #9669-B
TOP = 22.09
INV IN = 17.30
INV OUT = 17.30

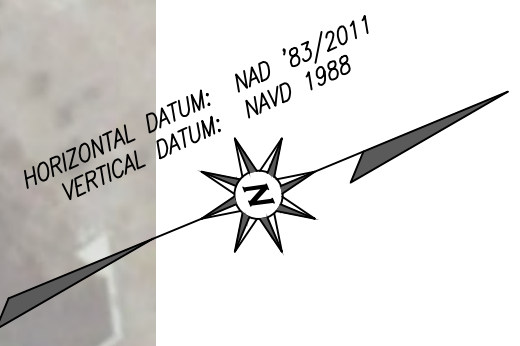

DESCRIPTION	
REV	
URS CORPORATION - NORTH CAROLINA LICENSE NUMBER C-2243 201 N. FRONT STREET, SUITE 509 WILMINGTON, NC 28401 TEL: 910.763.8063	
DESIGNED BY: N. LAURETTA	CHECKED BY: S. THOMAS
DRAWN BY: N. LAURETTA	PROJ. MANAGER: D. HOYLE

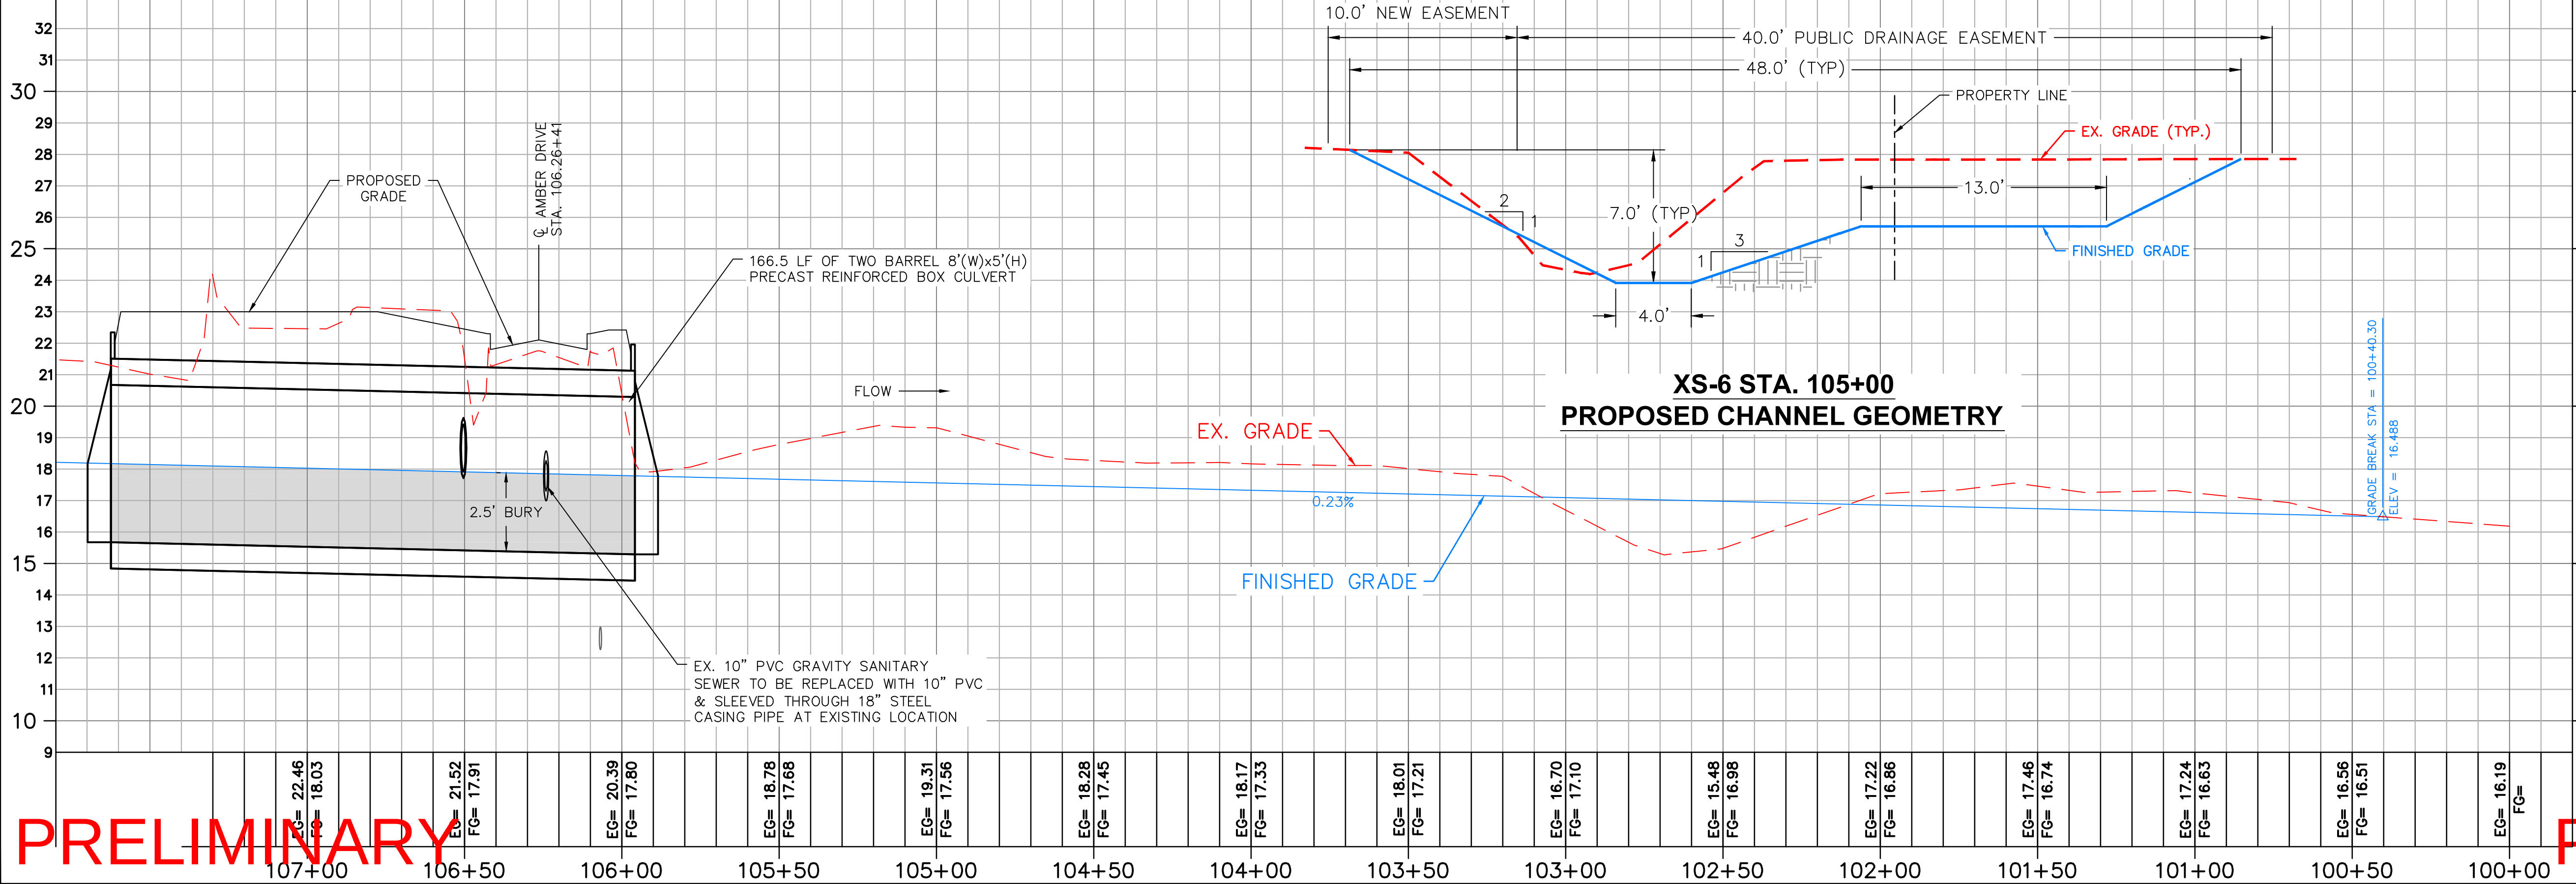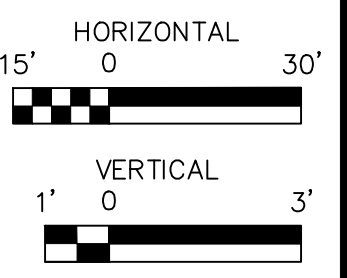

- LEGEND
- EX. MAJOR CONTOUR
 - EX. MINOR CONTOUR
 - PROP. MAJOR CONTOUR
 - PROP. MINOR CONTOUR
 - DEED PROPERTY LINE
 - EX. STORM DRAINAGE
 - EX. SANITARY SEWER
 - EX. WATER LINE
 - EX. OVERHEAD POWER
 - EX. STORM DRAINAGE EASEMENT
 - PROP. STORM DRAINAGE EASEMENT
 - EX. SURVEYED TOP OF BANK
 - BUFFER & MAINTENANCE CORRIDOR
 - STREAM CENTERLINE
 - FENCE LINE
 - ROAD CENTERLINE
 - EDGE OF PAVEMENT
 - WOODS LINE


PRELIMINARY

PRELIMINARY

CITY OF WILMINGTON - STORMWATER SERVICES BROOKSHIRE LANE/BEASLEY ROAD STORMWATER IMPROVEMENTS CITY OF WILMINGTON CONTRACT NO. SG-0511.2 DAVID B. MAYES, PE, STORMWATER SERVICE MANAGER	
DITCH #2 - PLAN AND PROFILE	
SHEET 5 OF 12 SHEETS SCALE: 1"=30'	
URS PROJECT # 31828773 DATE: 03/11/14	
C-105	


PRELIMINARY

PRELIMINARY

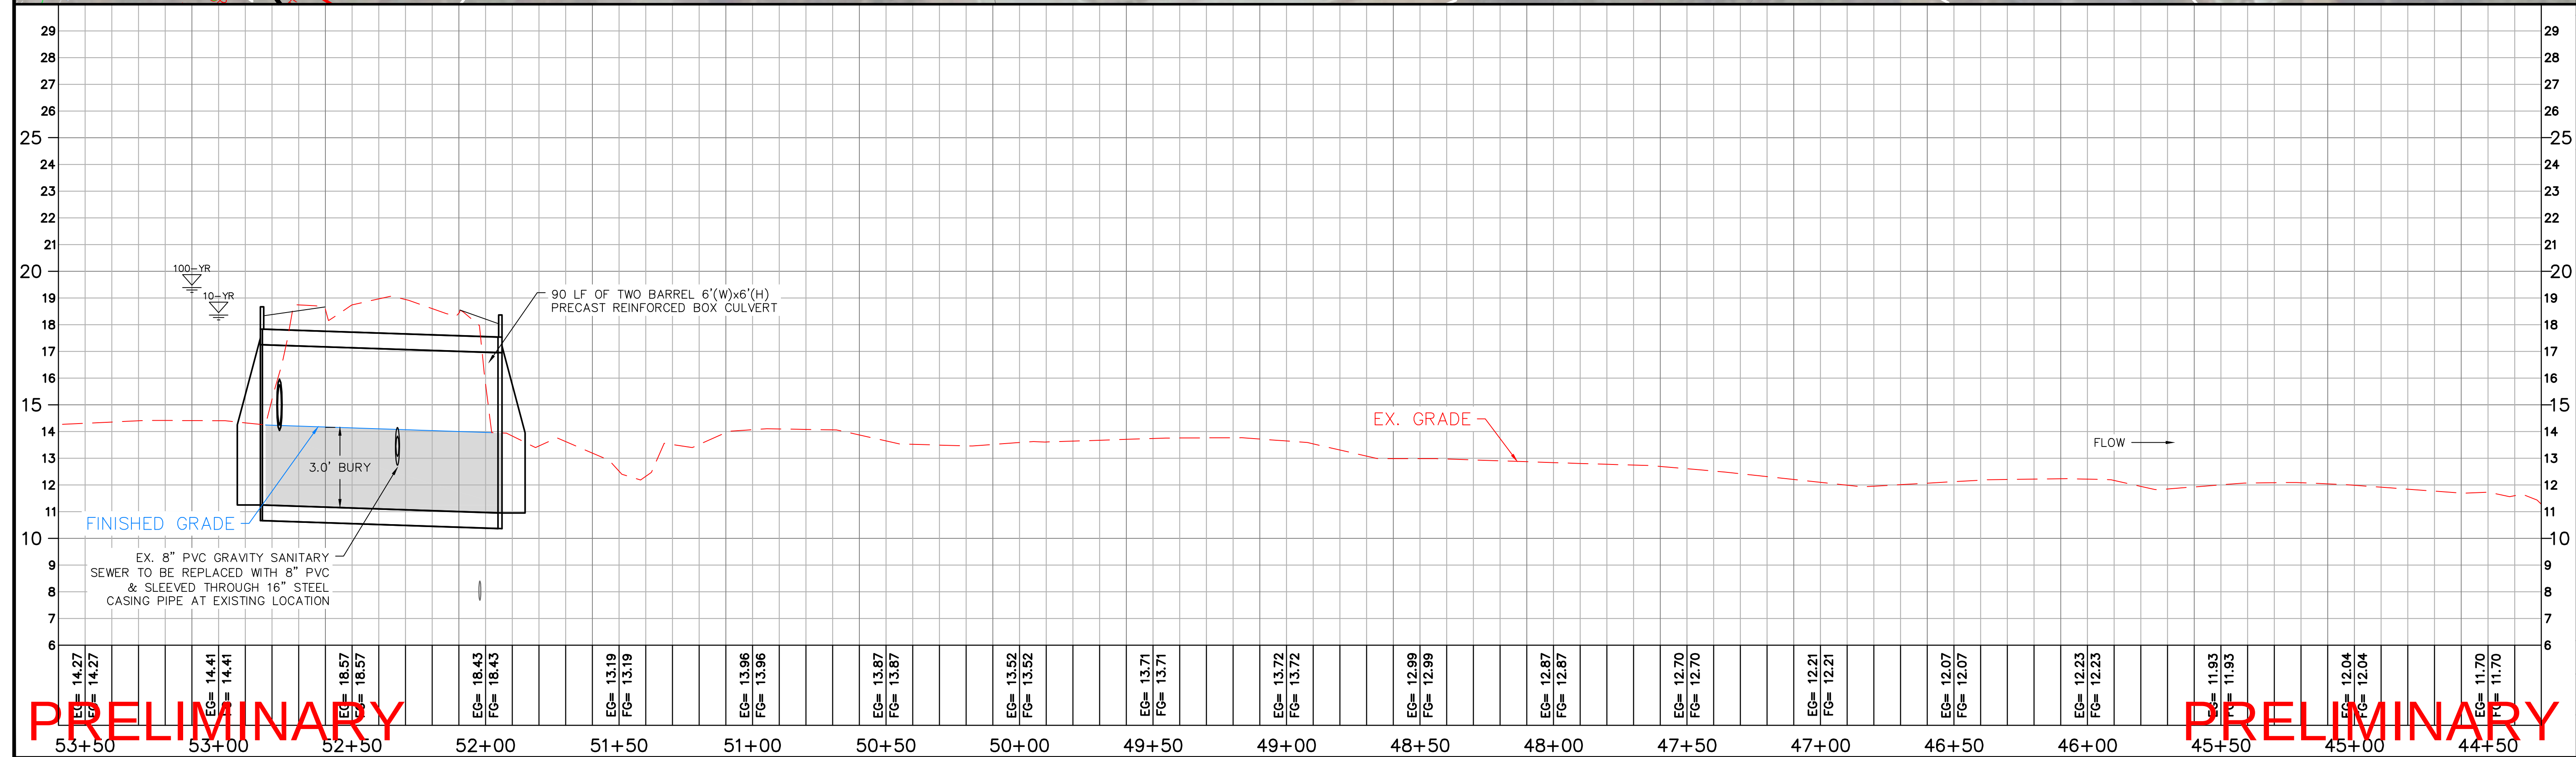[illegible]


PRELIMINARY

PRELIMINARY

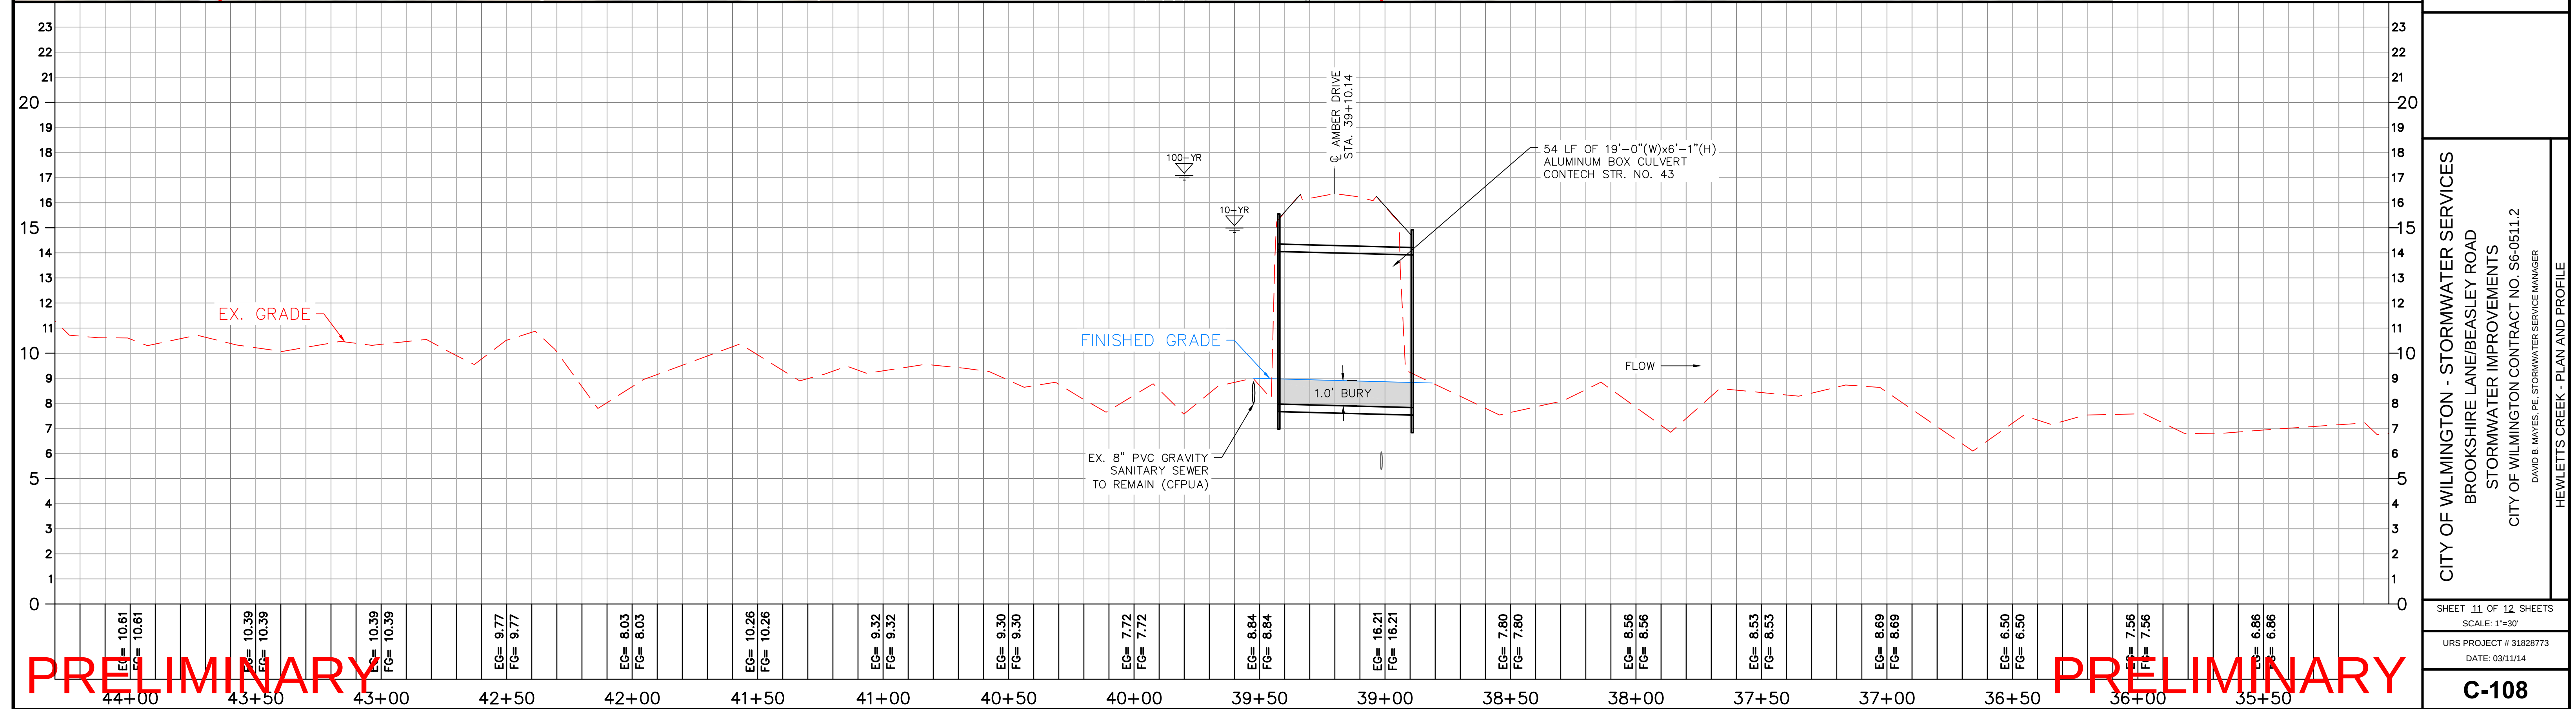


PRELIMINARY

PRELIMINARY

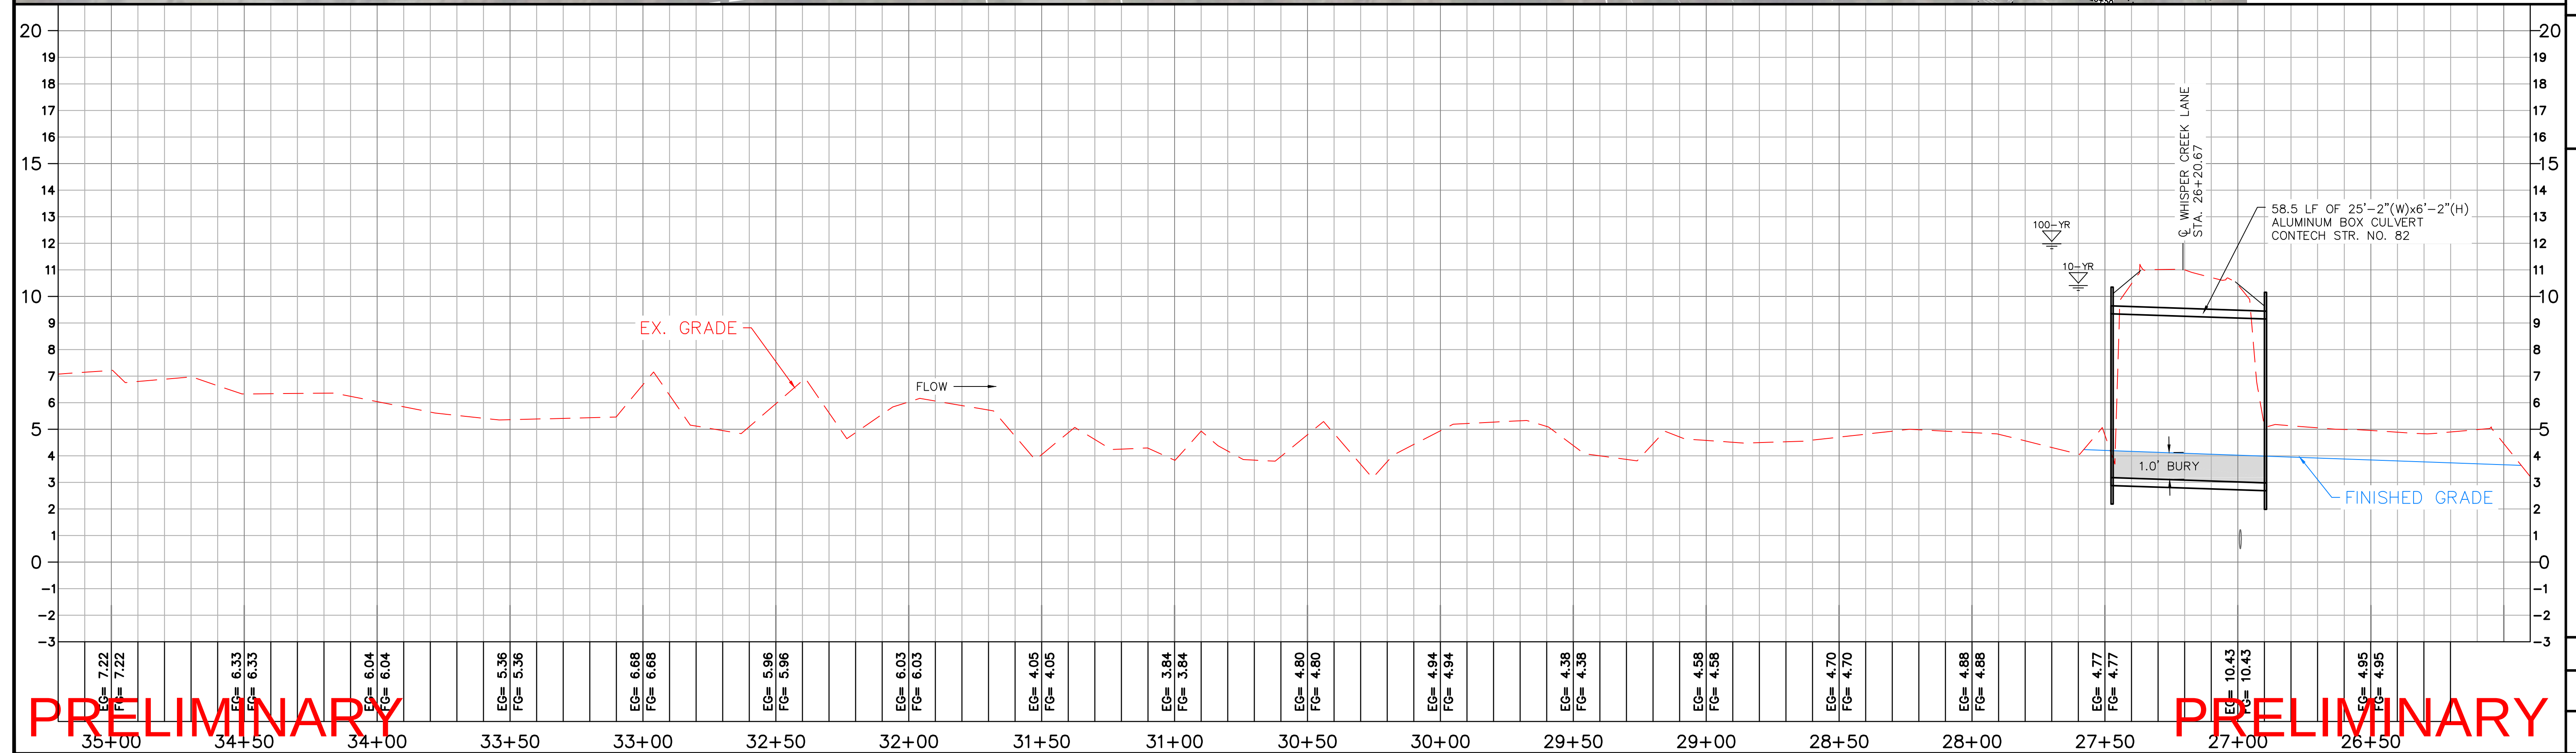[illegible]

PRELIMINARY

PRELIMINARY

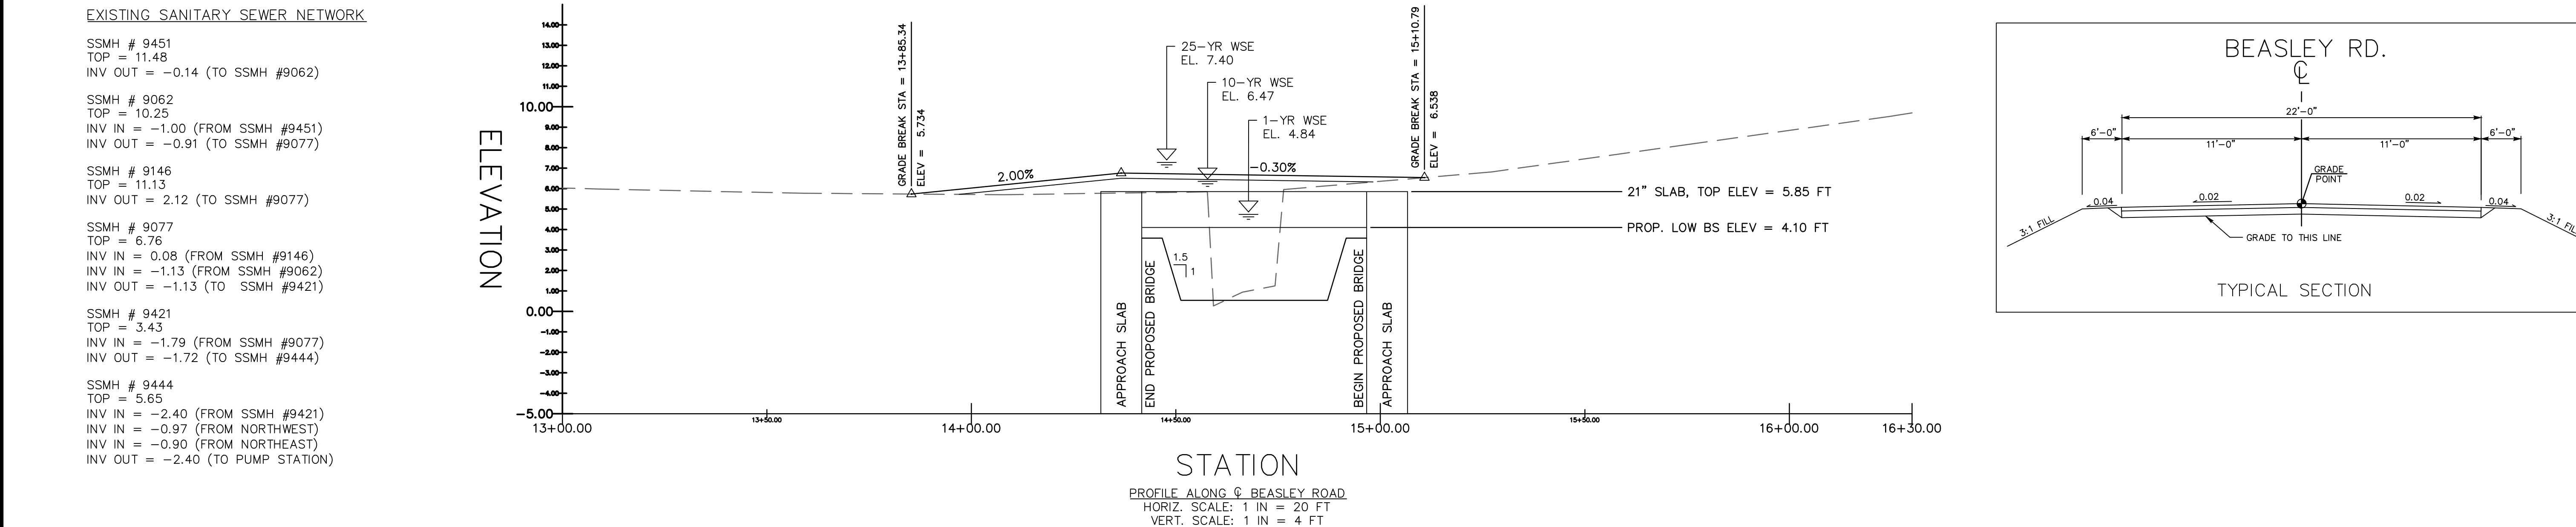

CITY OF WILMINGTON - STORMWATER SERVICES BROOKSHIRE LANE/BEASLEY ROAD STORMWATER IMPROVEMENTS CITY OF WILMINGTON CONTRACT NO. S6-0511.2 DAVID B. MAYES, PE, STORMWATER SERVICE MANAGER	URS CORPORATION - NORTH CAROLINA LICENSURE NUMBER C-2243 201 N. FRONT STREET, SUITE 509 WILMINGTON, NC 28401 TEL.: 910.763.8063		DESIGNED BY: N. LAURETTA DRAWN BY: N. LAURETTA CHECKED BY: S. THOMAS PROJ. MANAGER: D. HOYLE	REV	DESCRIPTION
SHEET 12 OF 12 SHEETS SCALE: 1"=20'		URS PROJECT # 31828773 DATE: 03/11/14			
C-112		BEASLEY ROAD BRIDGE - PLAN AND PROFILE			